




NB:- Due to the use of small scale drawings some items of equipment, ducts, pipe runs etc have been positioned with a view to clarity. Similarly the electrical and mechanical details indicated on them are not necessarily shown in their correct relative sizes. For these reasons reference should be made to both the mechanical and electrical drawings when ascertaining the scope of the works and the integration of the engineering services.
The position of all items of equipment, including luminaires, will be agreed with the Client before installing.

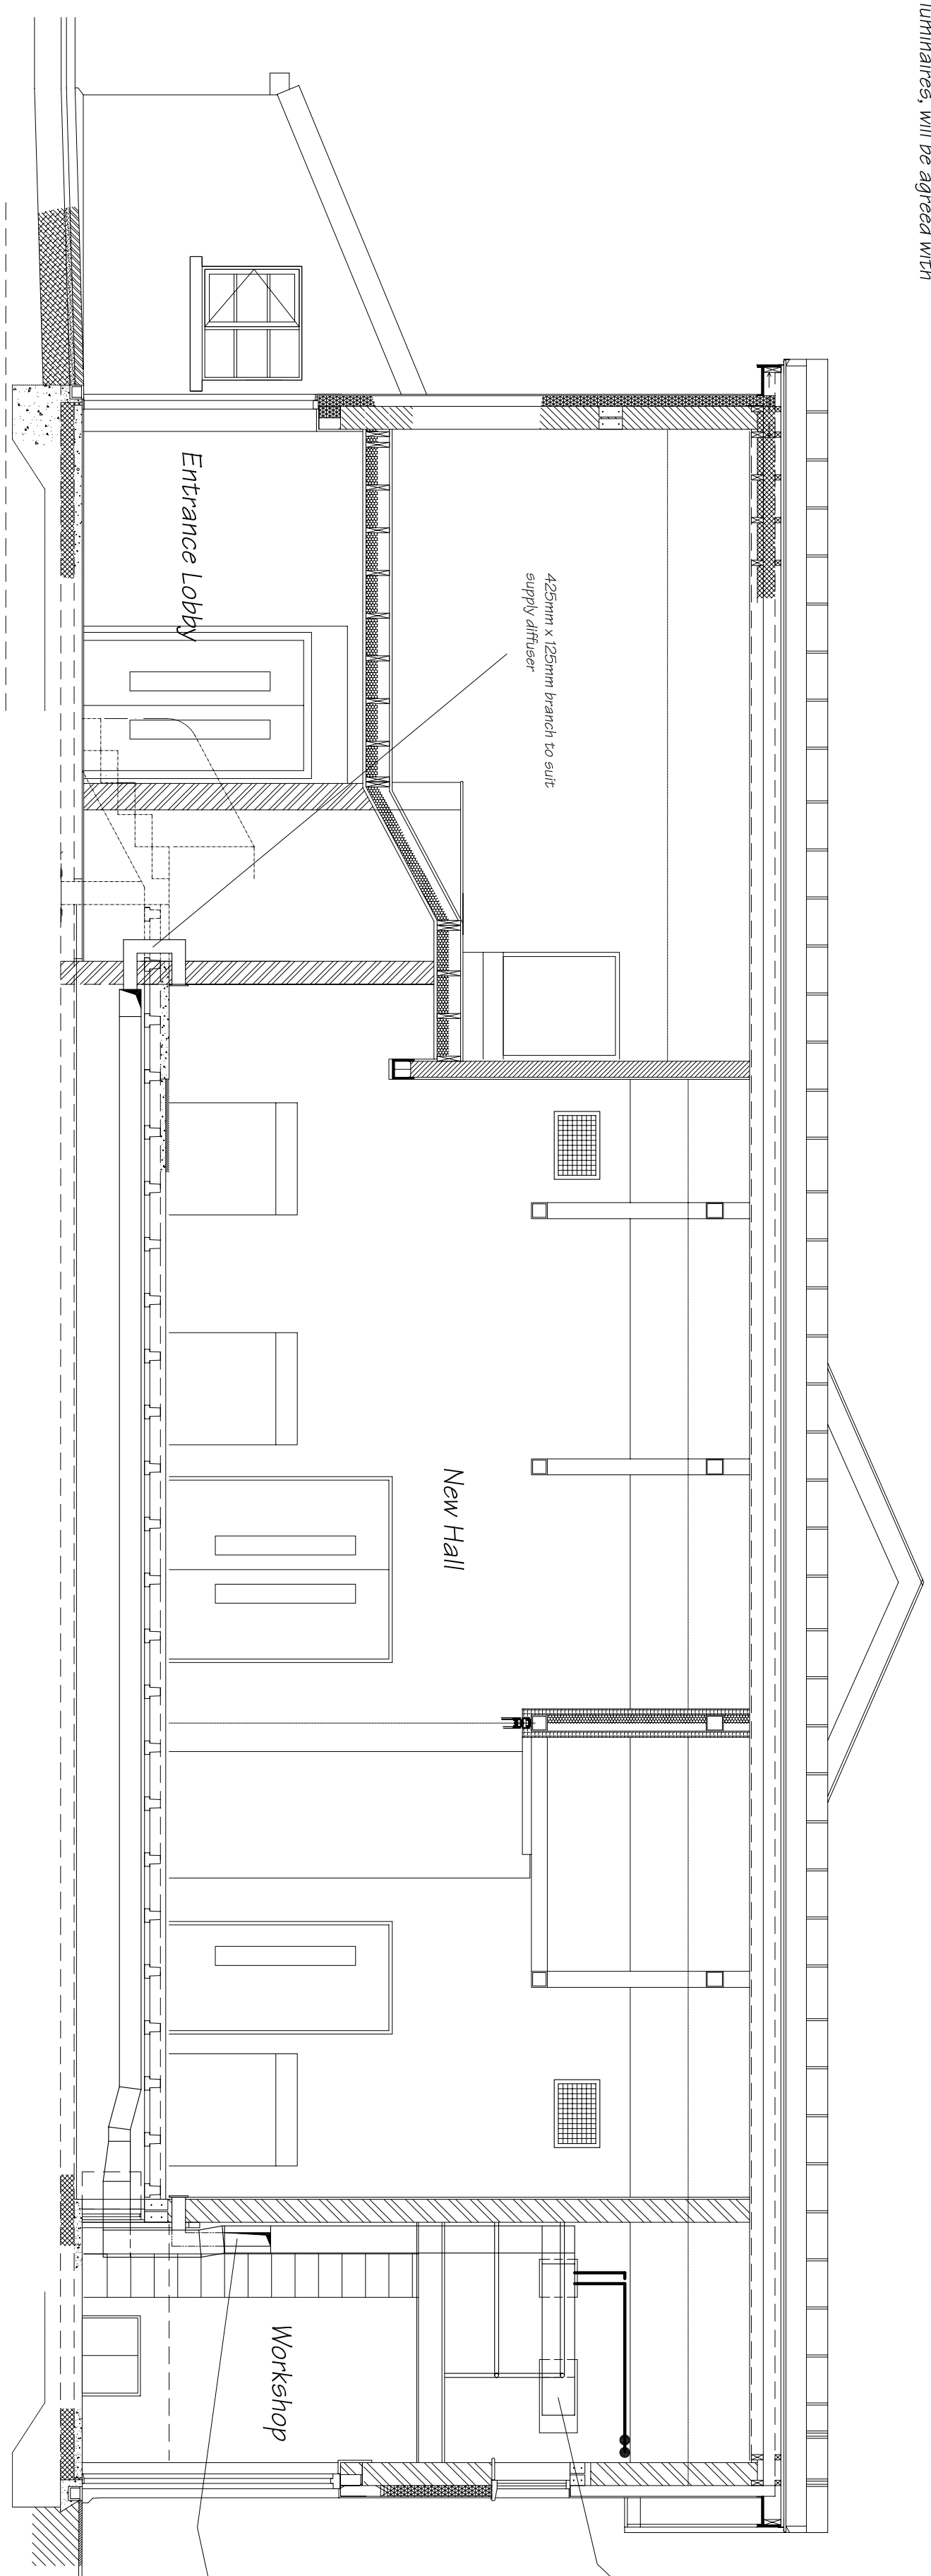

View through building on section A - A

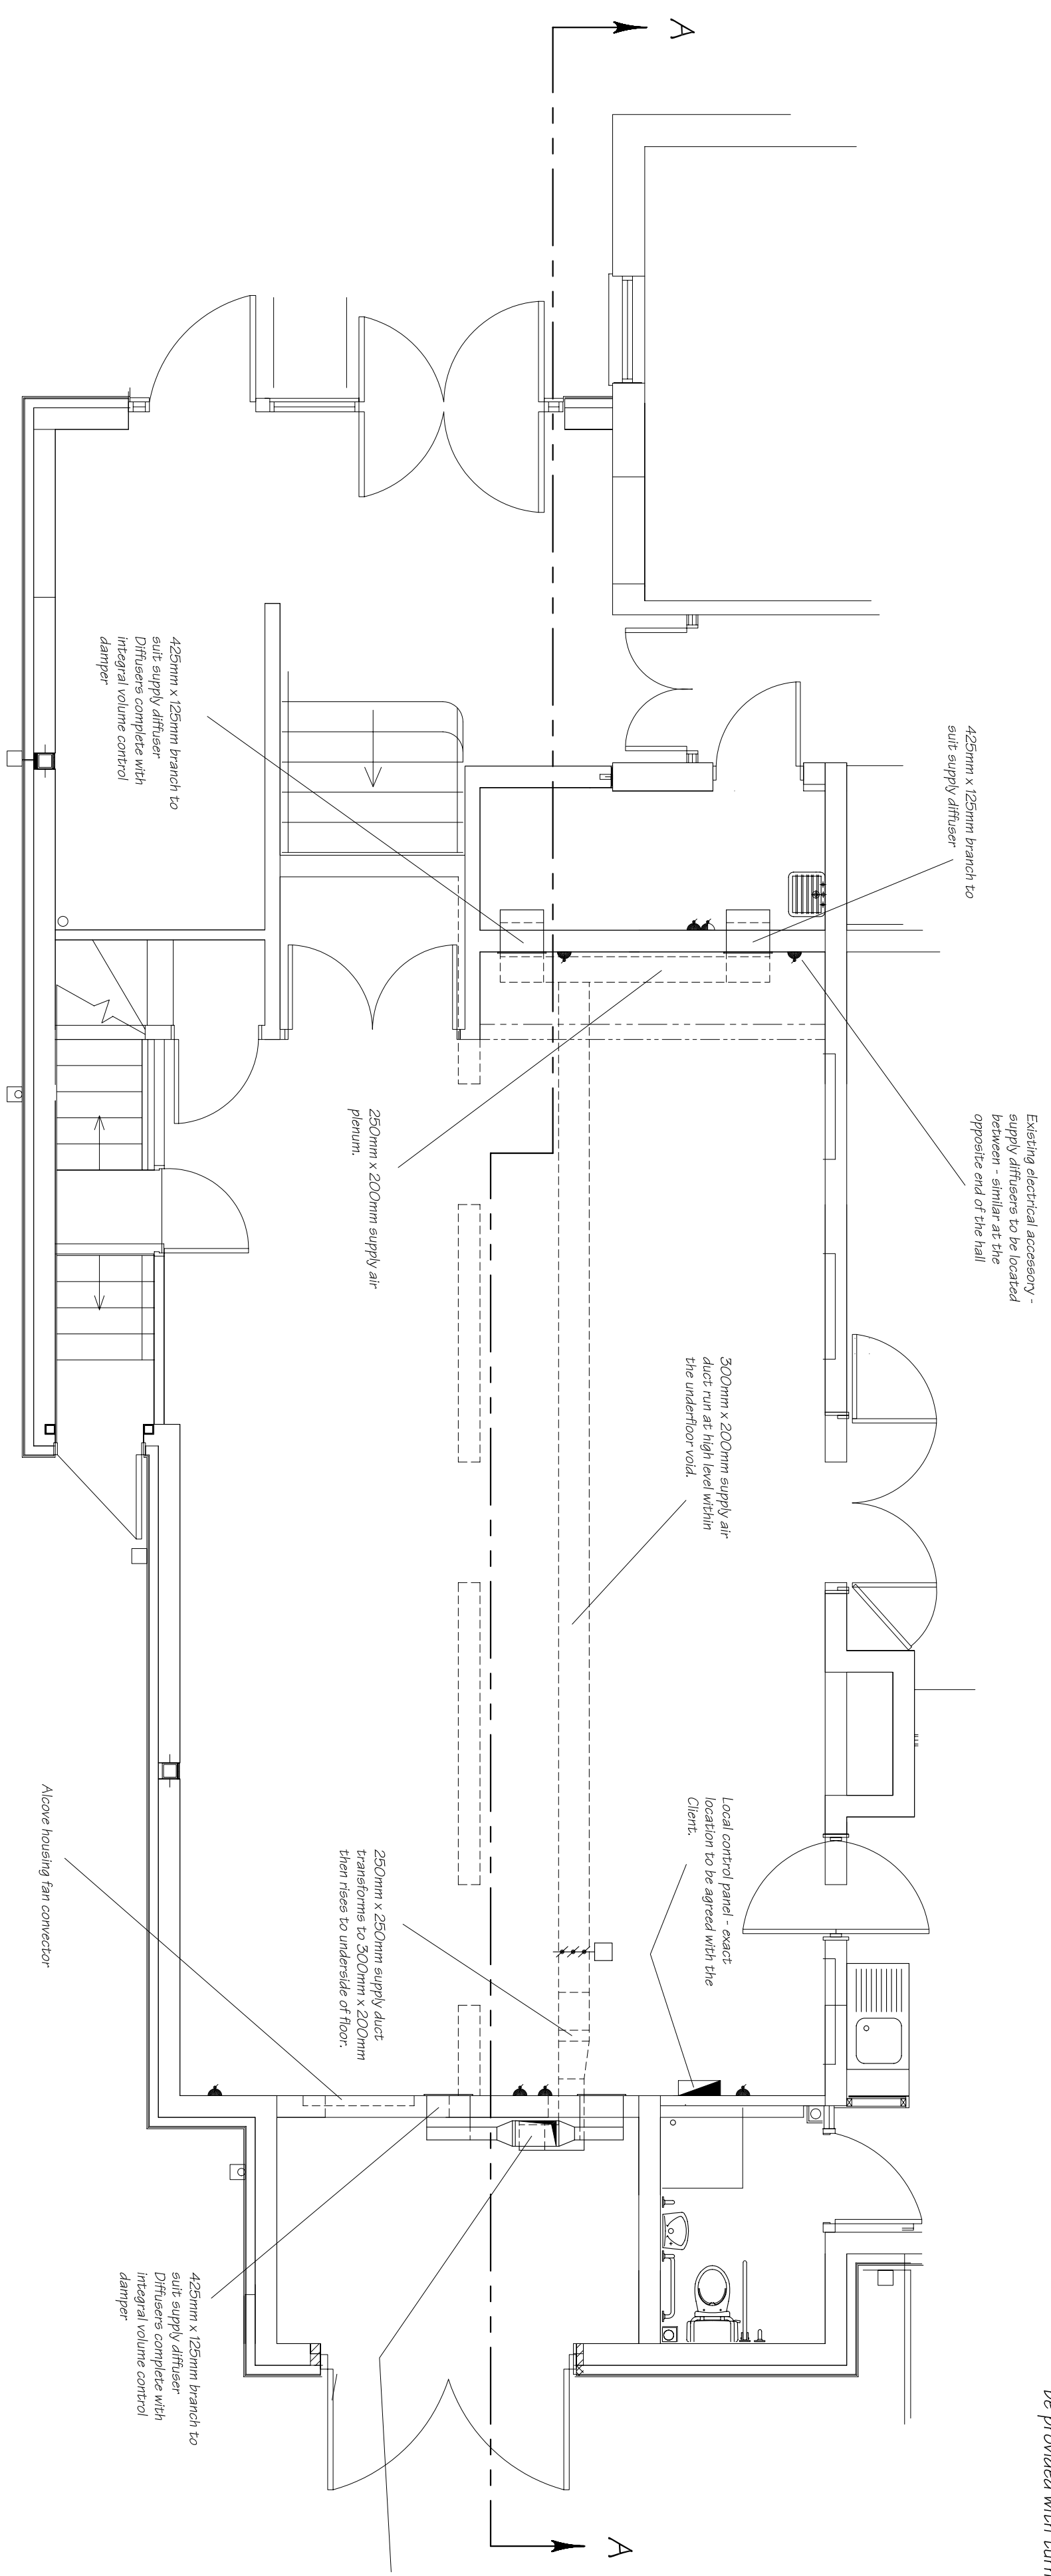

NB:- All bends in rectangular ductwork to be provided with turning vanes.

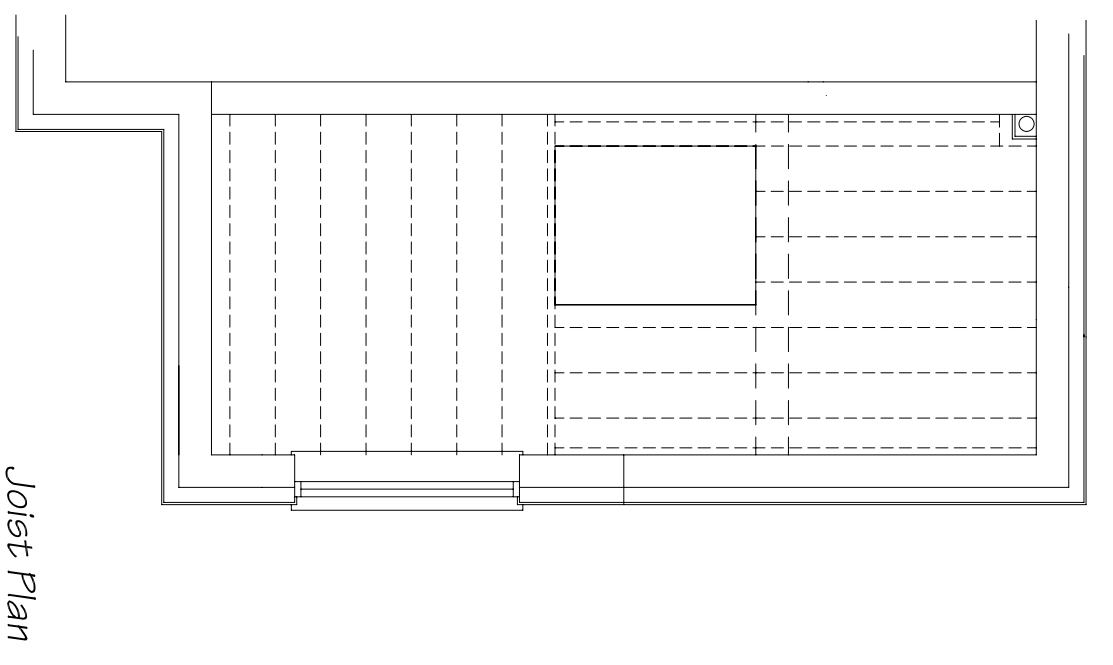

Joist Plan

Notes
All Dimensions Must be Checked on Site and Not Scaled from this Drawing.

ADRIAN TESTER
Building Services Engineer
6 High Street
Aberystwyth
SY23 1UG
Tel: (01970) 824510

Project
Neuadd Dyfi Hall
Provision of Ventilation

Drawing
Proposed Ventilation Installation - Layout II

Drawing No.	14 - 822
Amendment	
Job No.	334
Scale	1 : 50
Date	May 2014
Drawn by	R